




LIGHT FIXTURE SCHEDULE		
A	6" Recessed LED Can	EATON-HALO E750ICAT 6" Airtight
B	LED Wall Sconce	
C	3000 Lumen LED Shop	METALUX AP -SHP LED
D	Wall Mtd. LED Strip Fixt.	EATON 'Define Series' Wall Linear
E	Stem Mtd. Exterior LED	BARN LIGHT ELECTRIC
F	Pendant Mtd. LED	EATON '144-P' Series
G	Barn Light	NORTHERN TOOL G19875
H	Security Light	LAMPS PLUS 'Style 14G91' 1600 Lumen LED
J	Bath Light Fan Combo	PANASONIC FV-05-11VKL1
K	Continuous LED Strip	INFIINILINE*X 120V LED LIGHT
L	12" Surface Mtd. LED	3000K LED

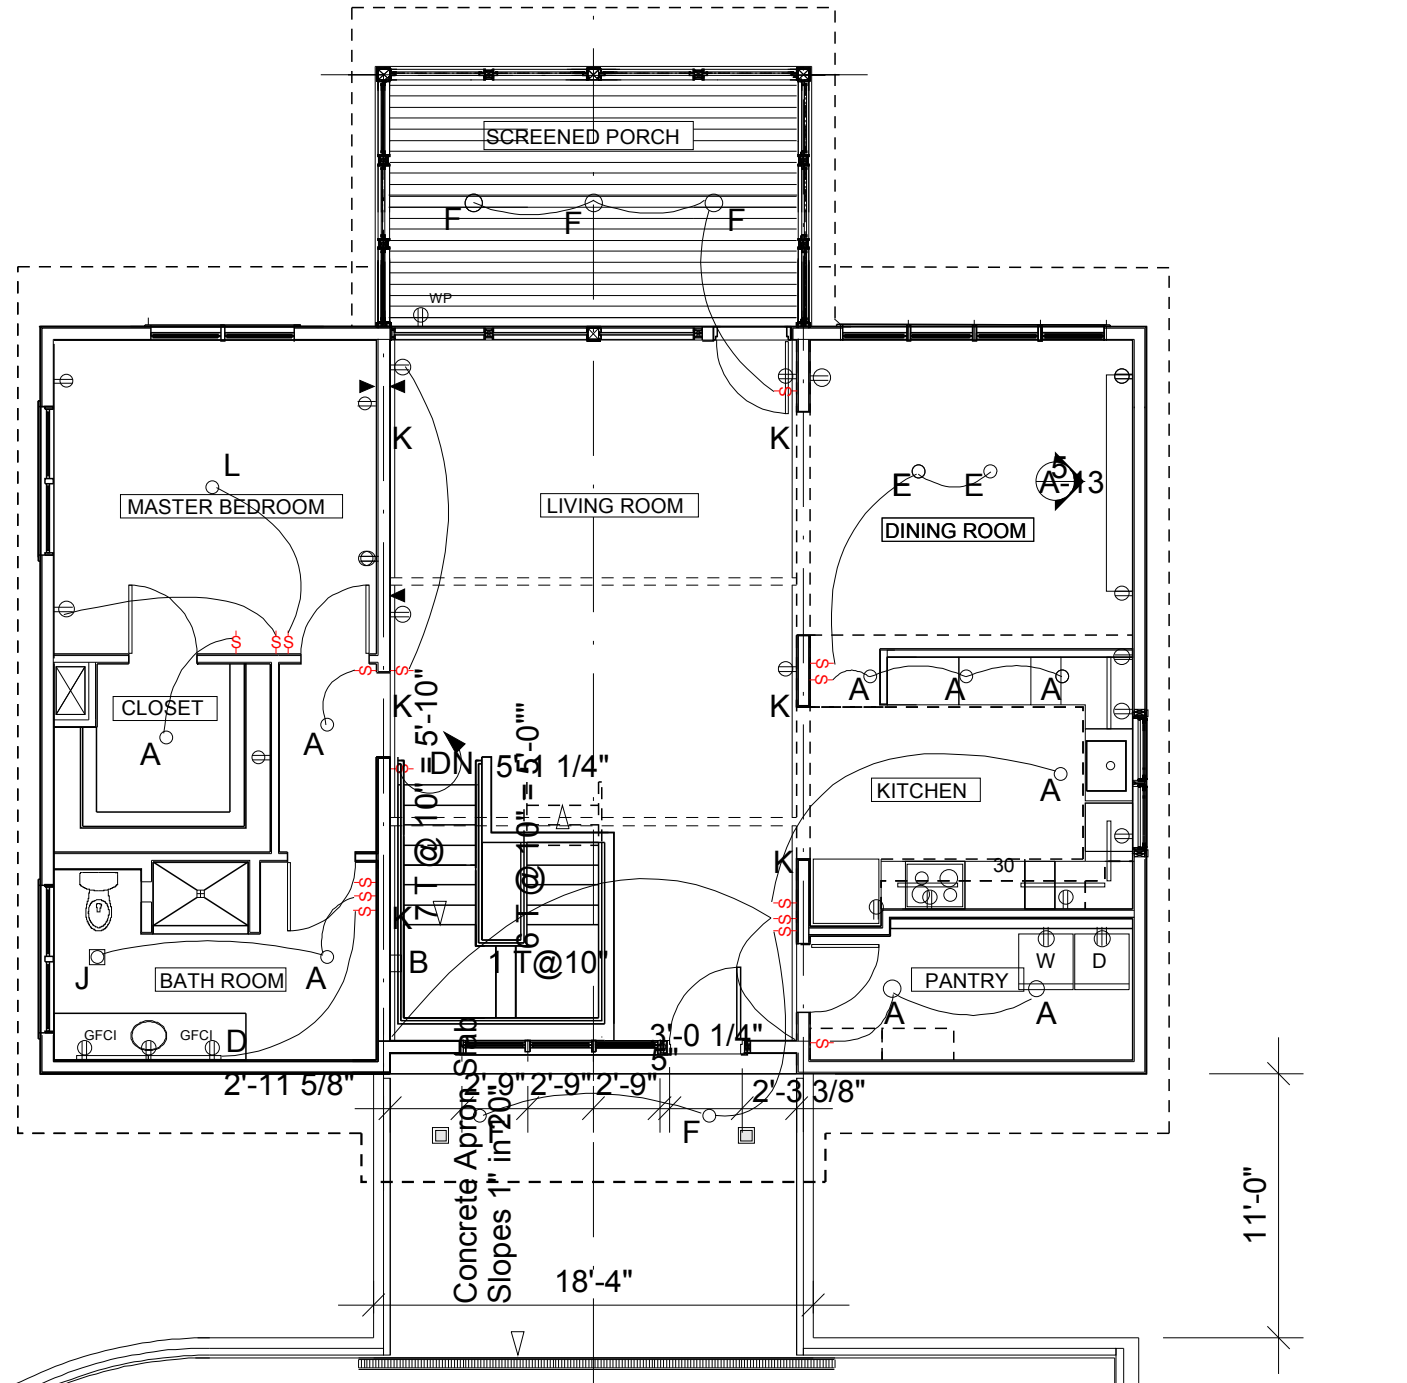

1 FIRST FLOOR POWER -LIGHTING
 A-16 Scale 1/8"=1'-0" LEV-1-FL_POWER-LIGHT

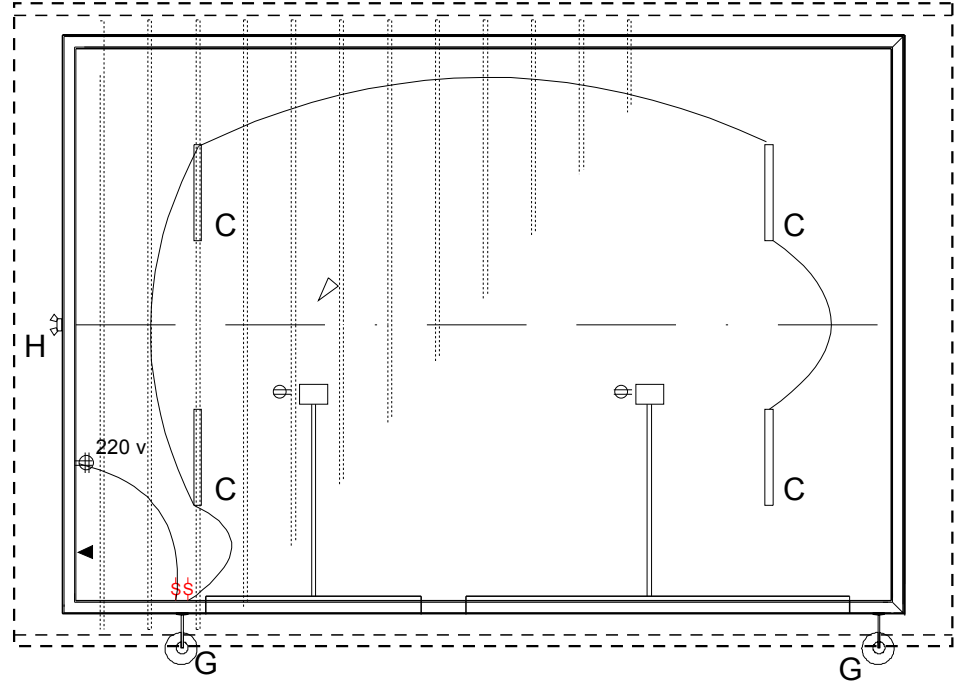

3 GARAGE-POWER-LIGHT
 A-16 Scale 1/8"=1'-0" 34FT-GAR_POWER-LIGHT

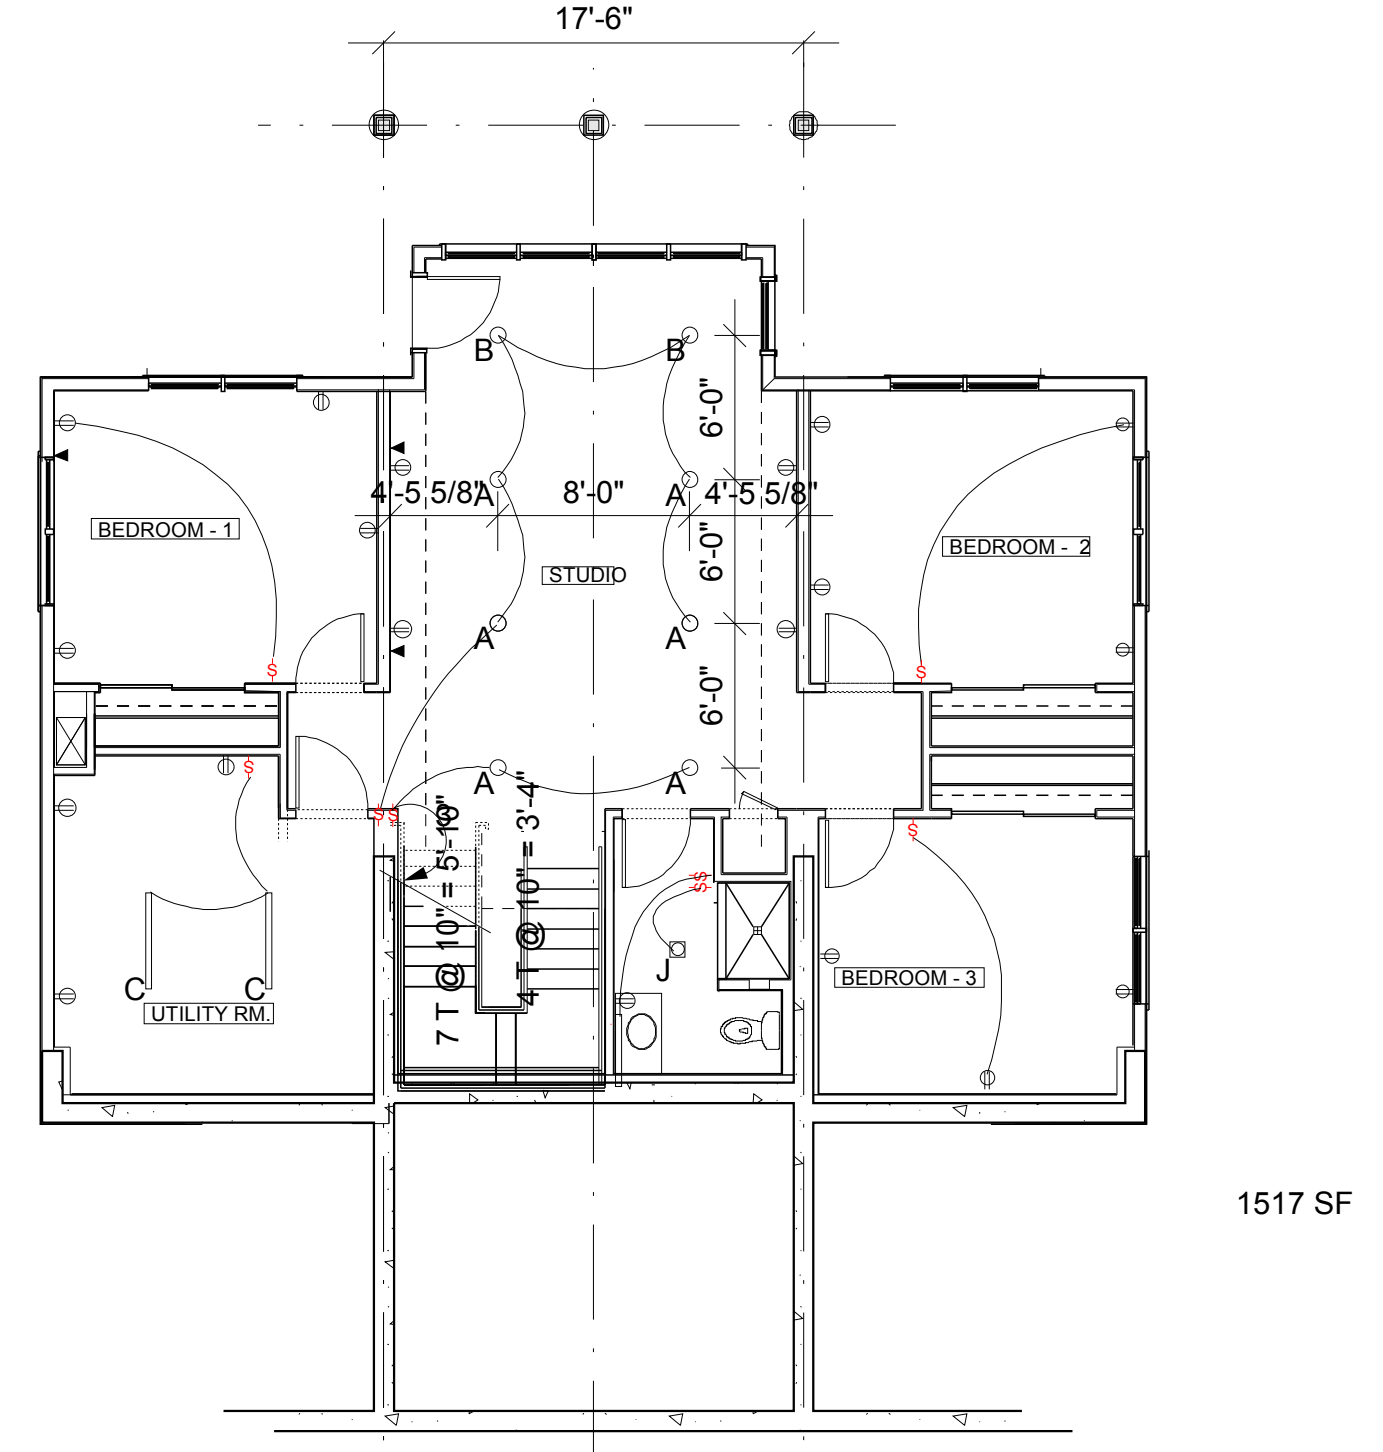

2 GROUND FLOOR POWER -LIGHTING
 A-16 Scale 1/8"=1'-0" LEV-LOWER-PLN_POWER-LIGHT

Expires 11/30/2018
MacLaren Residence
 51 FAIRVIEW LANE
 SPRINGFIELD IL
 Architect:
 Robert E. Edmonds
 7158 Waterman Ave
 St. Louis, MO 63130
 314-324-9333
 reedmonds@yahoo.com

A-16
 POWER-LIGHTS-PLAN